


GENERAL NOTES:
 1. ALL DIMENSIONS ARE IN MM UNLESS UNTIL IT IS SPECIFIED.
 2. THIS DRAWING IS PREPARED IN CONJUNCTION WITH THE LATEST ARCHITECTURAL, STRUCTURAL & MEP DRAWING RECEIVED AS MENTIONED IN THE DRAWING REFERENCES GIVEN BELOW.

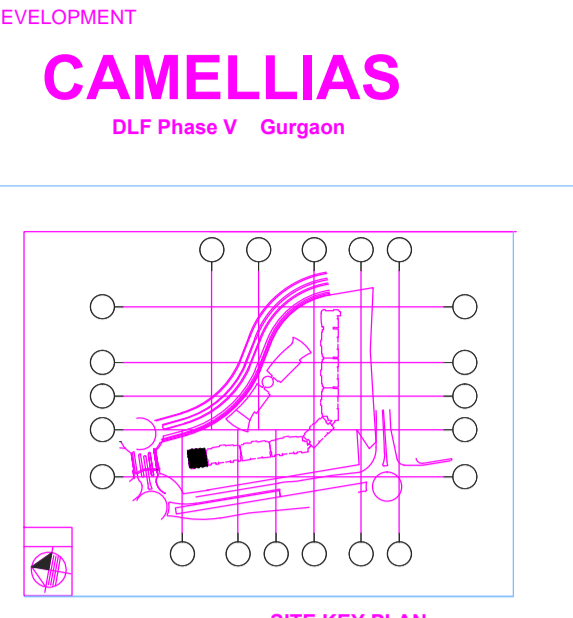

SITE KEY PLAN

DEVELOPMENT
CAMELLIAS
 DLF Phase V Gurgaon

CLIENT
DLF LIMITED.
 DLF Gateway tower, R Block, DLF City, Phase III,
 Gurgaon-122002, Haryana(India)
 Tel: 91 124 4769000, Fax: 91 124 4769250.

PROJECT MANAGEMENT CONSULTANTS
Hill International
Hill International Project Management (India) Pvt. Ltd.
 Unit 1-2-3, 1st Floor, Augusta Point,
 Sector 53, Golf Course Road, Gurgaon, India.
 Tel: +91 124 4076314

ARCHITECTS
Architect Hafeez Contractor
 29 Bank Street, Mumbai 400023, Tel 22
 22661920, Fax 22 22664737

STRUCTURAL ENGINEERS
CBM Engineers India
 101, Sai Avenue, Amritsar Road, Vija Road,
 Kharakola, Gurgaon - 122002
 Ph: (0129) 2481835
 Email: cbm@cbmengineers.com
 Website: www.cbmengineers.com

MEP Consultants
Meinhardt India Pvt Ltd
 A-8 Sector 16, Noida 201-301 UP India Tel: 91
 120 2516165, Fax: 91 120 2516745

FIRE FIGHTING CONSULTANTS
Tenable - Fire Engineering Consultancy
 Middleview, Faringdon Road, Southmoor,
 Oxfordshire OX12 5BG, T 44 186 5821482, F
 44 777 853 3965

COSTING CONSULTANTS
KPK - Cost Consultants
 865 Mountbatten Road #07-01, Kalong
 Shopping Centre, Singapore 437944, Tel 65
 963300 Fax 65 962633

QUANTITY SURVEYORS
KPK Quantity Surveyors India Pvt Ltd,
 816 Viasa Deep Towers, District Centre Janak
 Puri, New Delhi, 110058

LANDSCAPE CONSULTANTS
MFP / M.PAUL FRIDBERG & PARTNERS
 41, East 11th street, New York, NY 10003

MAIN CONTRACTOR
Leighton India Contractors Pvt Ltd
 3/F, Tower-A, Ocus Technopolis, Golf Course
 Road, Sector 54, 122002 Haryana, India

Rev no	Description	Drawn	Checked	Date
R0	FOR INFORMATION	BALAJI	TARUN	16.05.14

Job # ---
 Issue : FOR INFORMATION
 SCALE: 1:100
 DATE: 16/05/14
 Drawn By BALAJI
 Checked By TARUN

DRAWING TITLE :
**BASEMENT-3
 BLOCK-A1
 HVAC LAYOUT**

SHEET NUMBER:
D01-DWG-BS3-HV-01-001
 SHEET 1/2

Architecture	BASE DRAWING REFERENCE	Drawing No.	Rev. No.	Date
1	GFC-AR-AHC-DWG-BS-B1-19	R2	02.06.14	
Structural				
1	D01-DWG-BS-CS-02-001A	R1	03.06.14	
MECHANICAL				
1	-----	--	05.06.14	