

FOR CONTINUATION REFER TO DRG. No. +++CSD+++B3-8311

FOR CONTINUATION REFER TO DRG. No. +++CSD+++B3-8315

FOR CONTINUATION REFER TO DRG. No. +++CSD+++B3-8323

1. DO NOT SCALE FROM THE DRAWINGS.
2. ALL DIMENSIONS ARE IN MM. UNLESS OTHERWISE NOTED.
3. THIS DRAWING SHALL BE READ IN CONJUNCTION WITH OTHER RELEVANT ARCHITECTURAL, STRUCTURAL, MECHANICAL AND ELECTRICAL DRAWINGS AND ALL PER DUCT INSULATION & SUPPORT DETAILS PLEASE REFER SPECIFICATION.


AP-CA-1010 CO ARCHITECTURAL PLAN RESIDENT-3
HW-CA-1010 CO HVAC SYSTEM PART PLAN
EL-CA-1010 CO LIGHTING LAYOUT PLAN
FA-CA-1010 CO FIRE ALARM LAYOUT PLAN

REV. 01
15-03-2016
ISSUED FOR APPROVAL

COORDINATED DRAWING
BASEMENT LEVEL -3
SHEET 14 OF 28

ABBREVIATIONS
BOP BOTTOM OF DUCT
BOB BOTTOM OF PIPE
COP CENTER OF PIPE
BOB BOTTOM OF TRAY
UP SET DOWN

1:8 MATCH 2:10	1:100
VIII	IV
+++ CSD +++ B3	8313
	AO

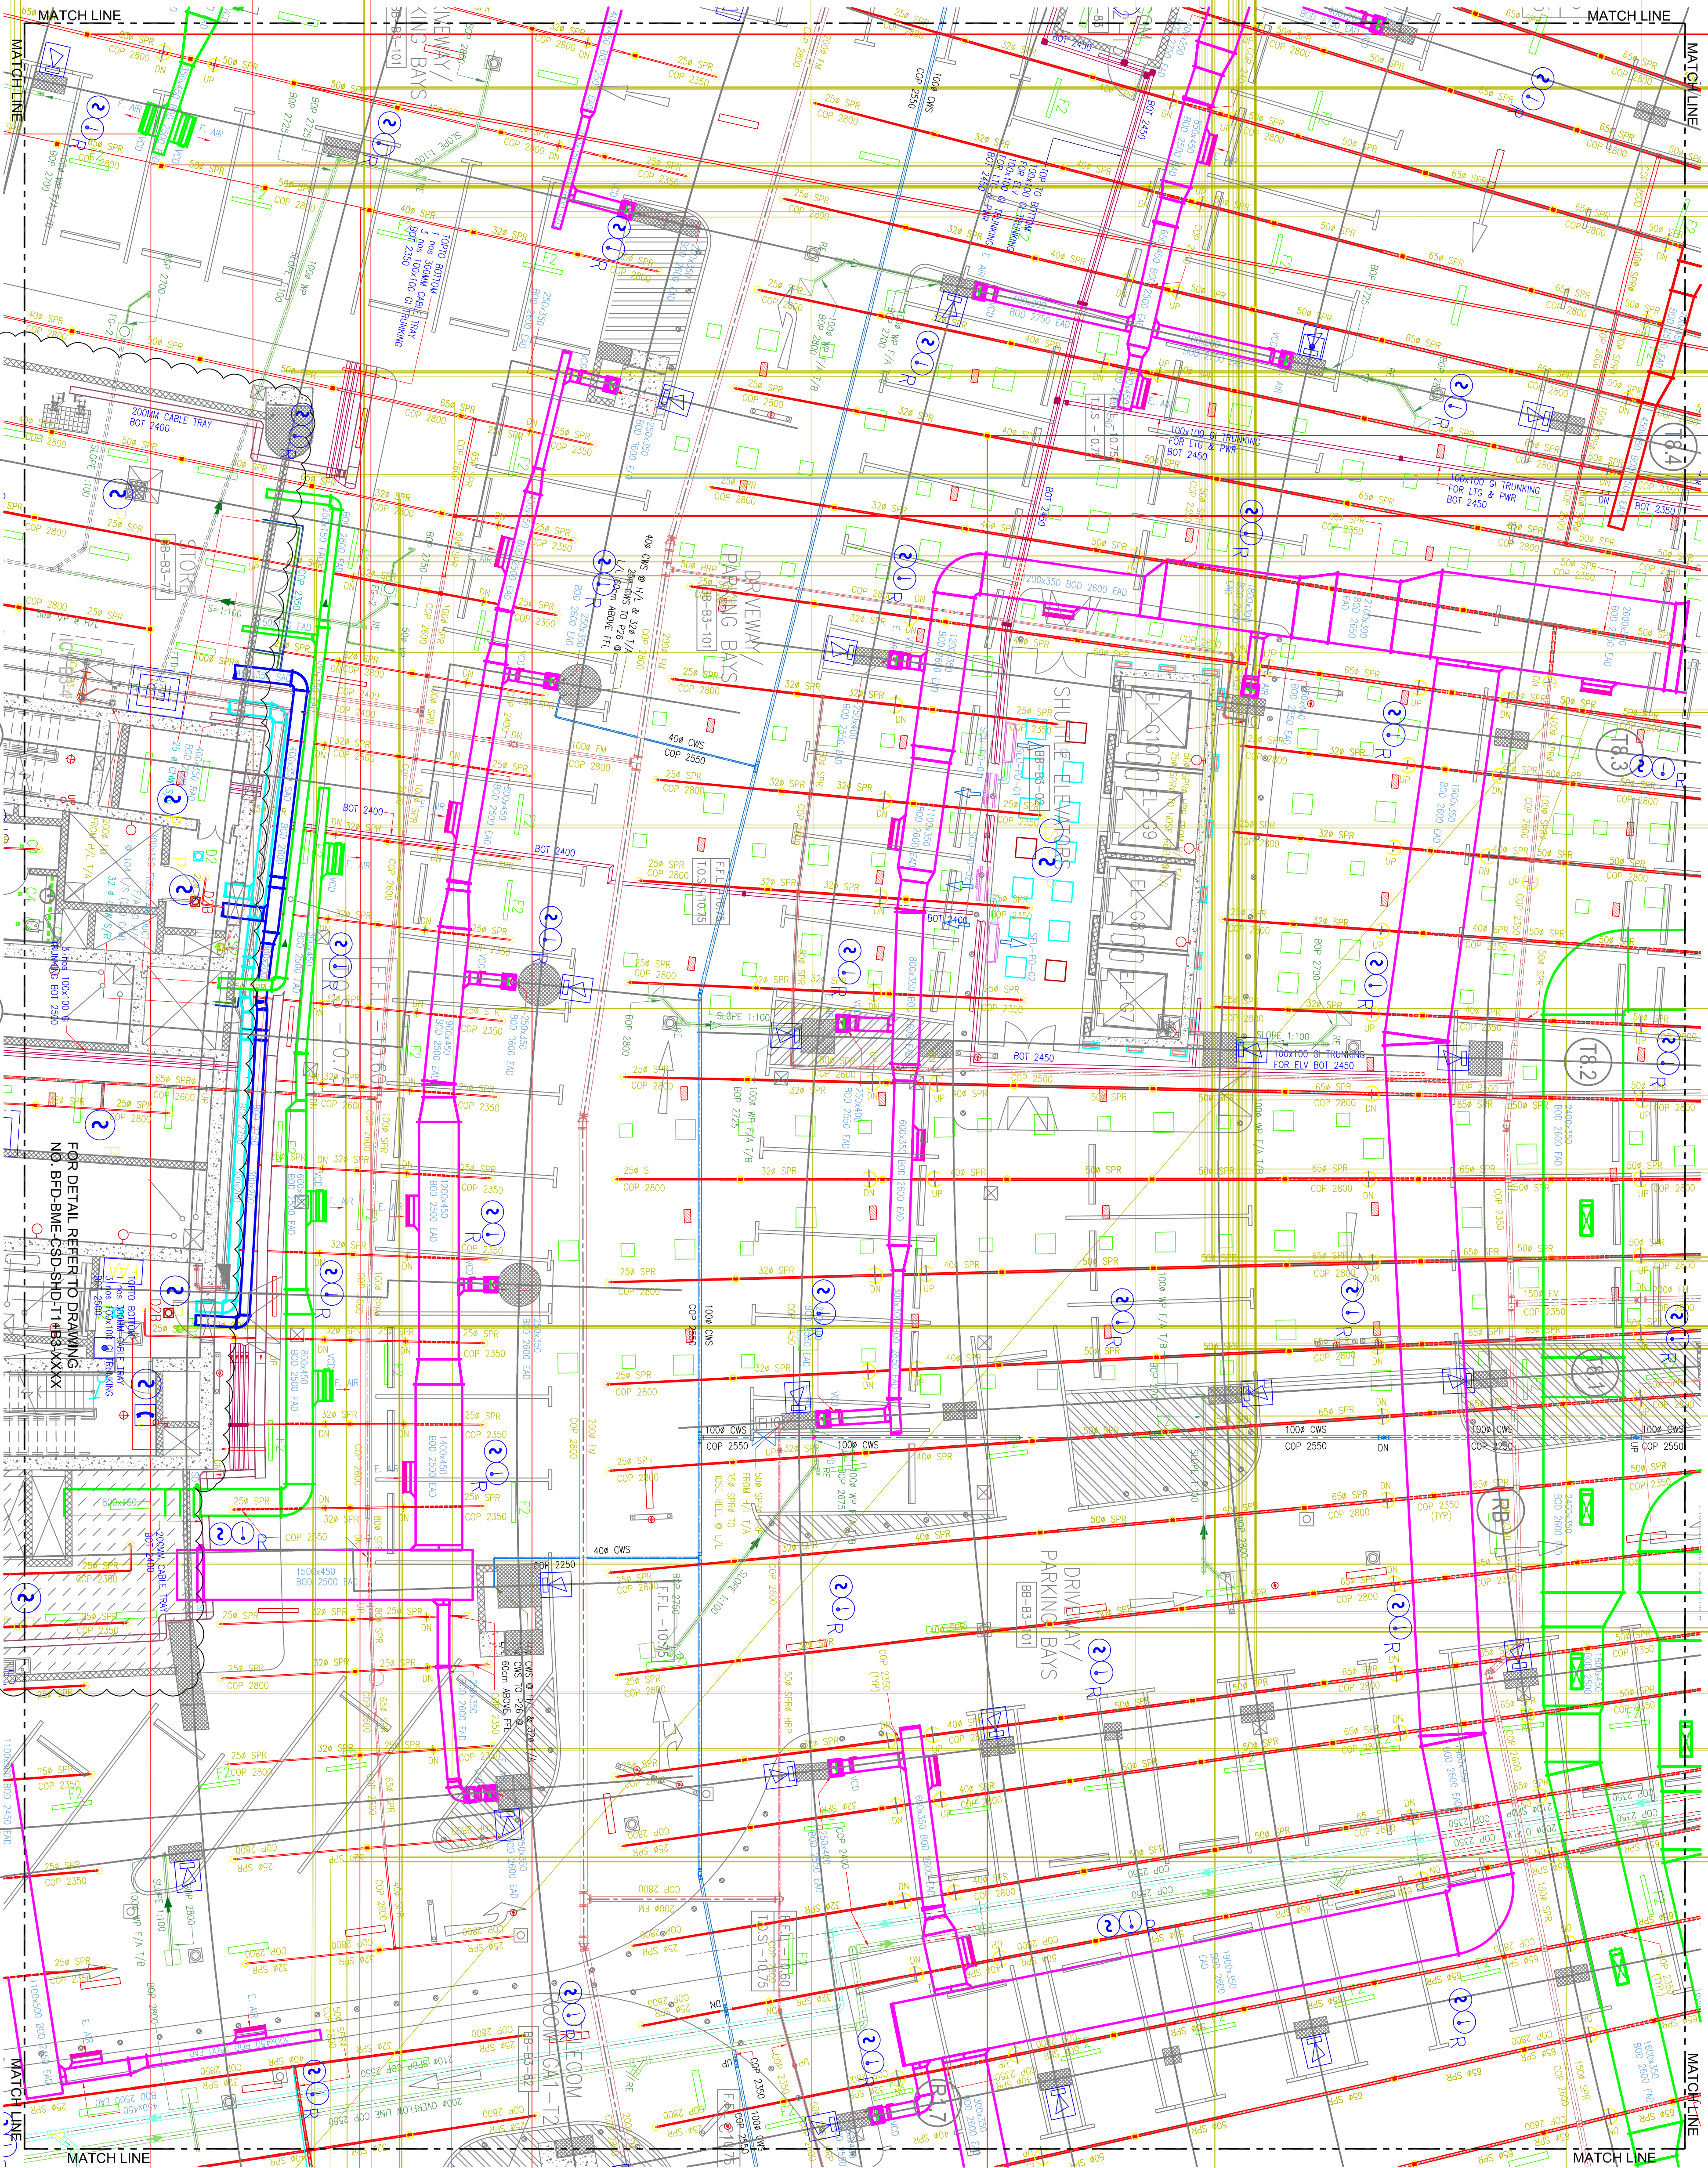

FOR CONTINUATION REFER TO DRG. No. +++CSD+++B3-8313